


LEGENDS:	
	CONVENTIONAL SMOKE DETECTOR
	CONVENTIONAL HEAT DETECTOR
	CONVENTIONAL FIRE ALARM BREAK GLASS
	CONVENTIONAL MONITOR MODULE
	FIRE ALARM CONTROL PANEL

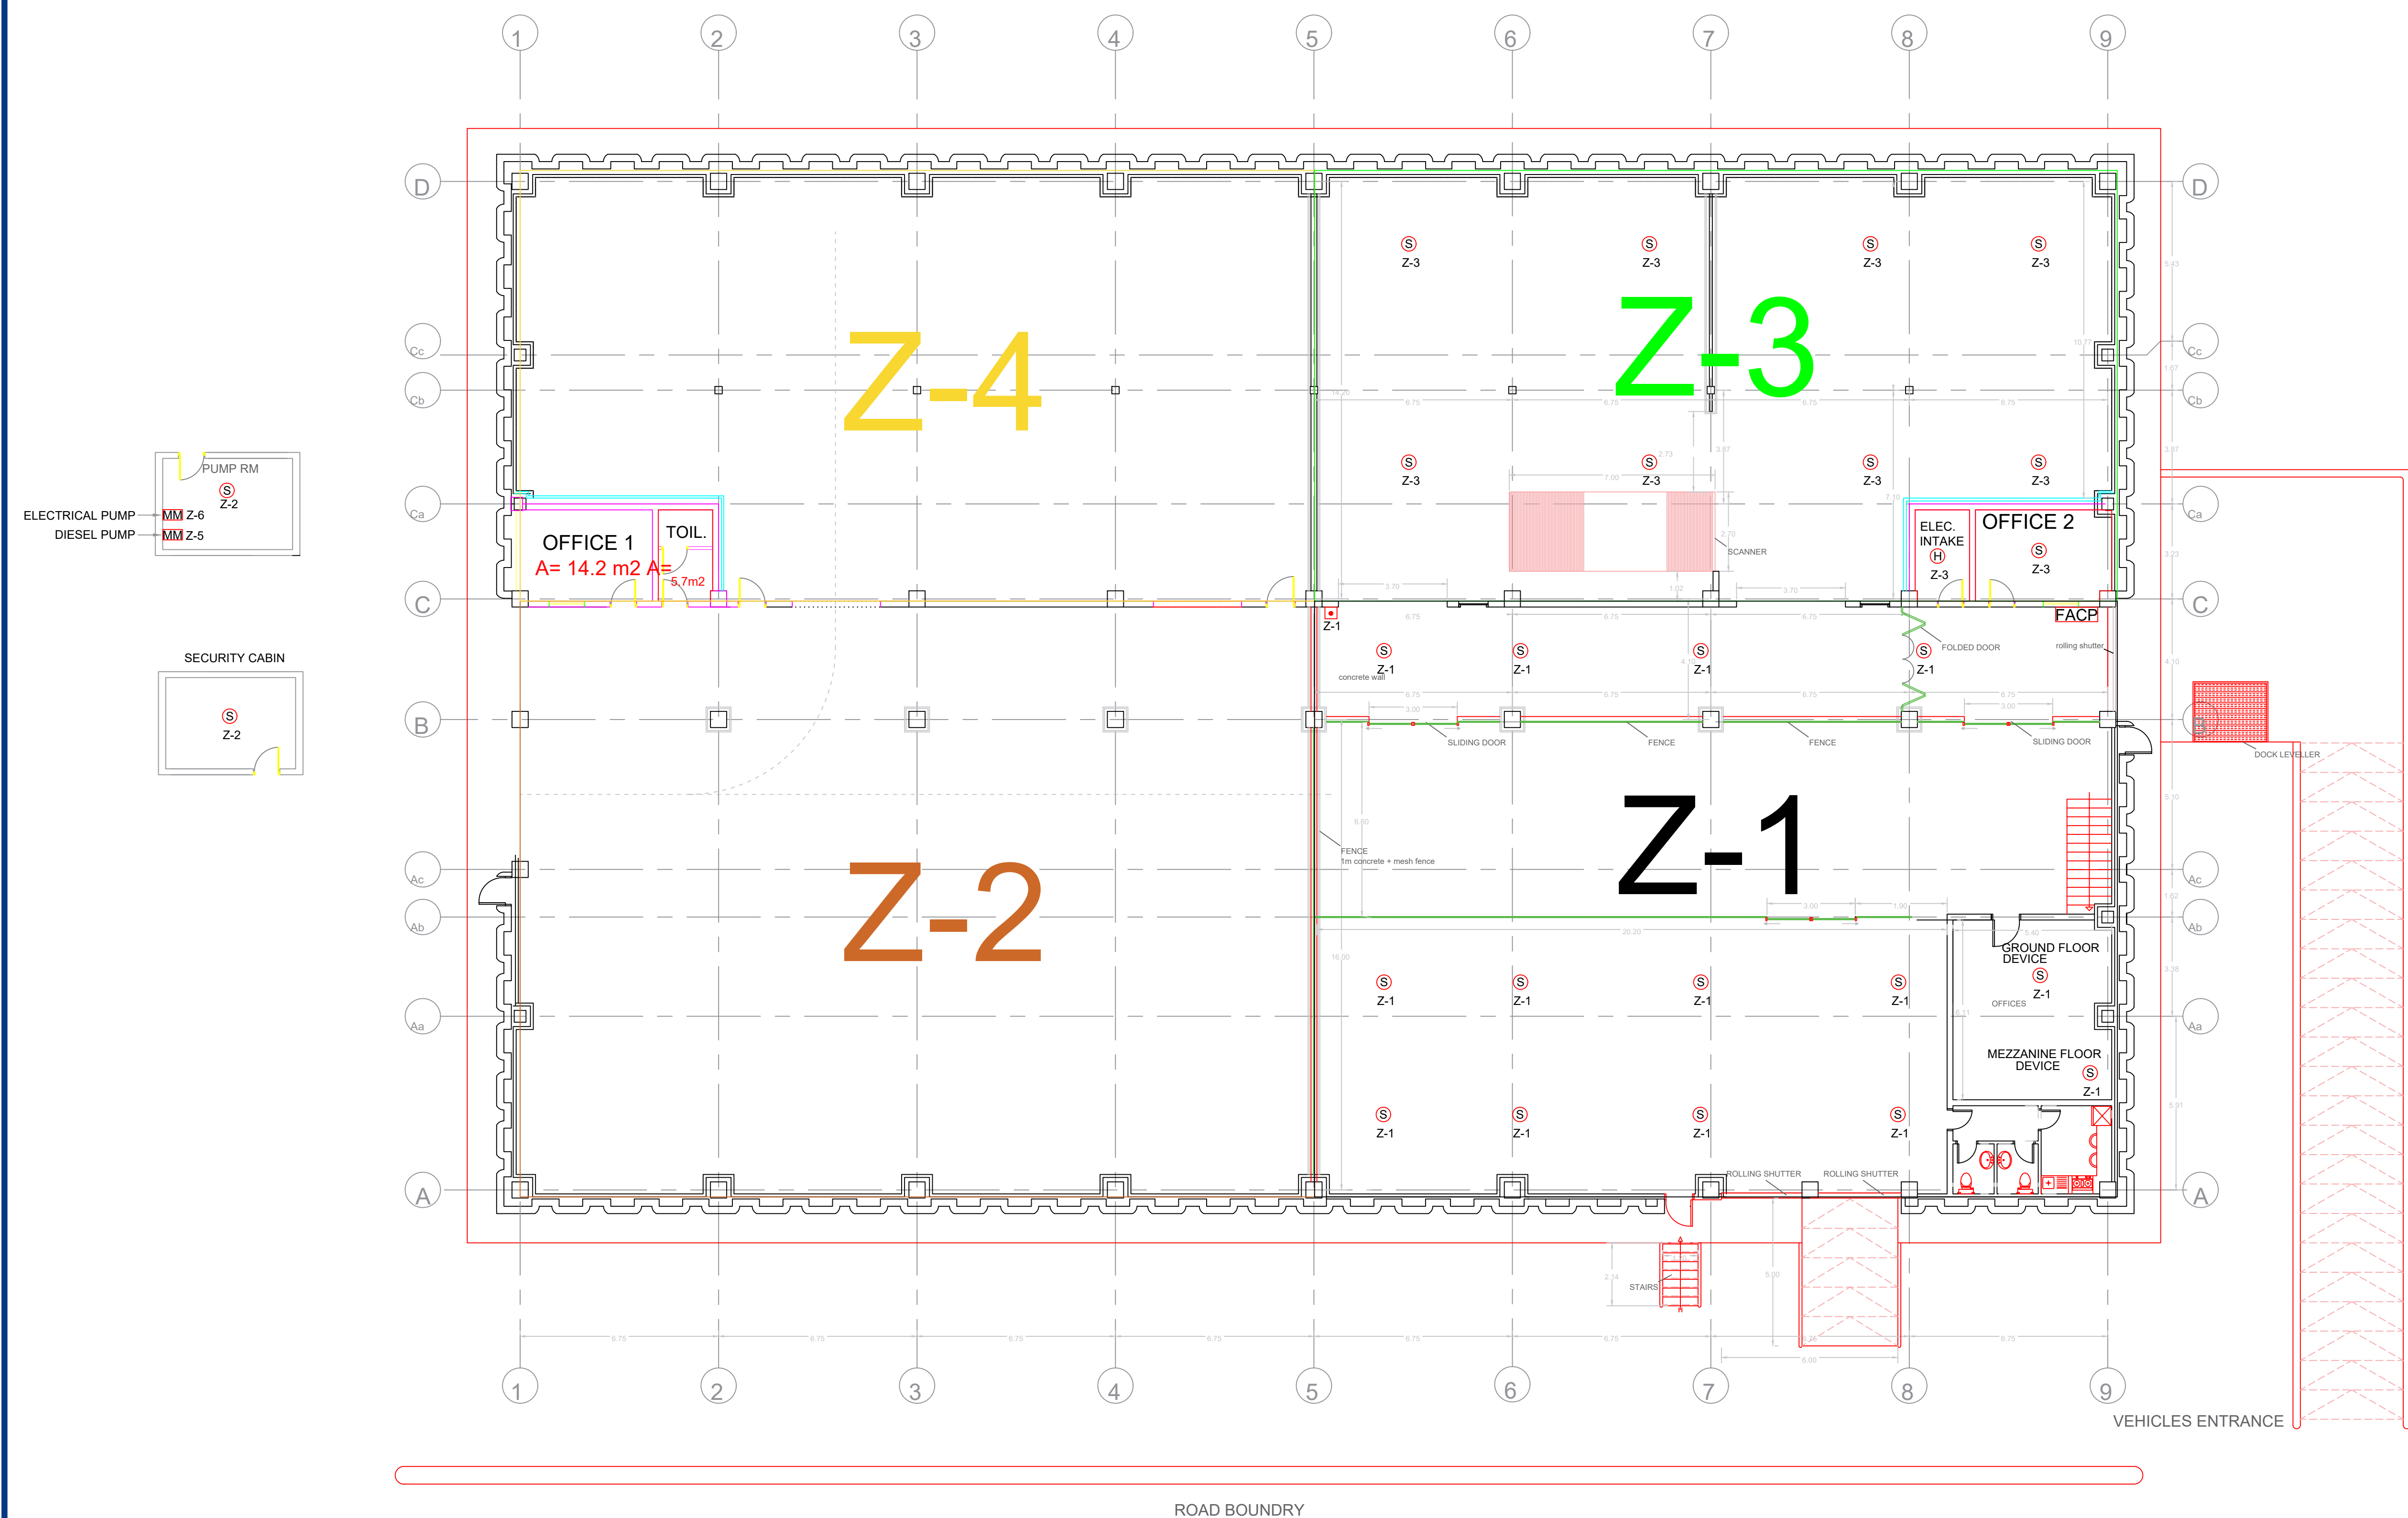


SAMSA WAREHOUSE GROUND FLOOR PLAN

FIRE ALARM SYSTEM :



S/NO.	REFERENCE DRAWINGS

SITE NORTH

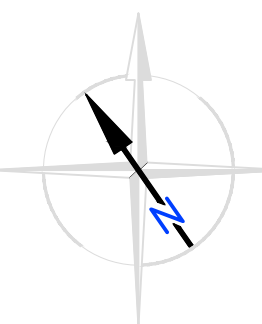

	DEPARTMENT:				STATUS:		--		PROJECT:	ABU DHABI INTERNATIONAL AIRPORT		DWG TITLE:				GROUND FLOOR PLAN FIRE ALARM SYSTEM LAYOUT SAMSA WAREHOUSE				Drawing No:				BEM-958F-LAY-FP-200											
	COMMERCIAL				APPROVED BY:		--													SHEET #:				1 of 1											
			1		JAM		21.03.2022													ISSUED FOR APPROVAL		CHECKED BY:		IBRAHIM		Scale:		NTS @ AO		AUH/ADIA		SAMSA-WH		FA GF/01	
			NO.		BY		DATE													DESCRIPTION		DATE:		25.09.2021		DRAWN BY:		ISMAIL							
																				REVISIONS															